












NOTES

LEGEND

-  SUPPLY AIR DUCT
-  RETURN AIR DUCT
-  FRESH AIR DUCT
-  CHILLED WATER SUPPLY
-  CHILLED WATER RETURN
-  CONDANSATE DRAIN
-  RETURN AIR DIFFUSER
-  FAN COIL UNIT
-  SA LINEAR SLOT DIFFUSER
-  RA LINEAR SLOT DIFFUSER

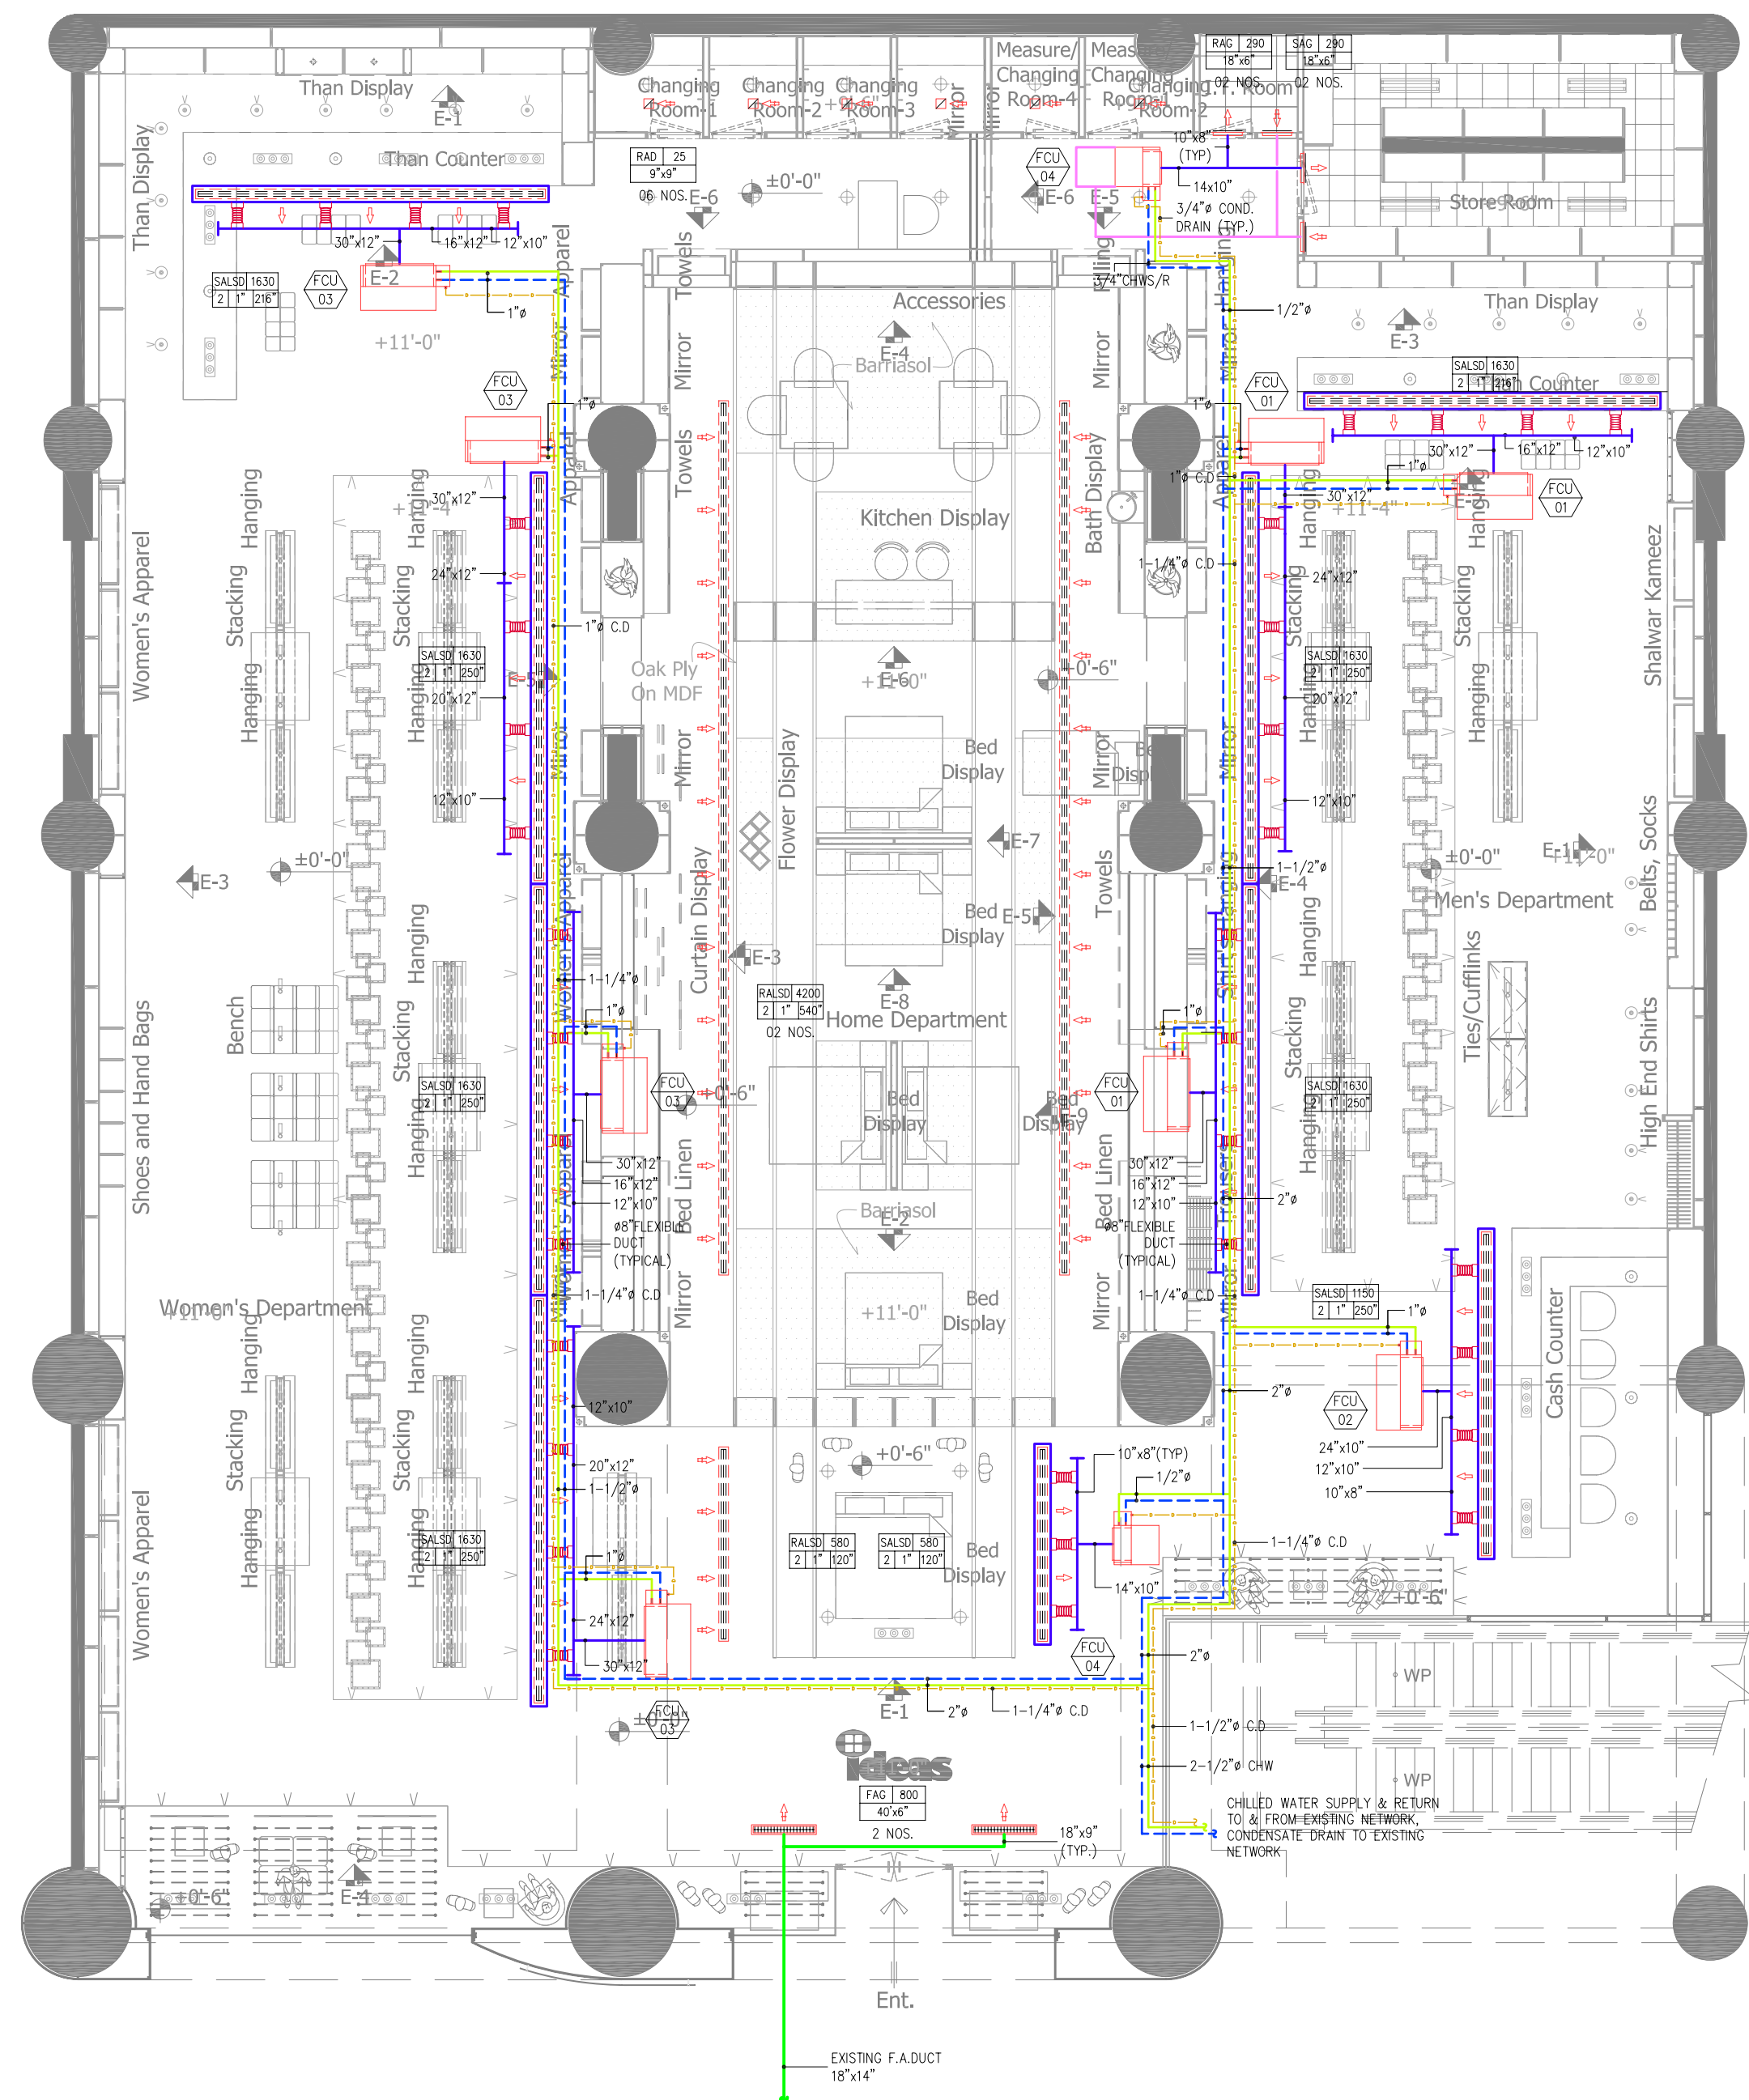

1 HVAC LAYOUT
 M.03 SCALE: 1/8"=1'-0"